


SPECIFICATION

S.NO.	SYMBOL	NAME OF PLANT
1.		SHRUBS/HEDGE
2.		ROYAL PALM
3.		MARIGOLD
4.		ROSE
5.		AMALTAS
6.		OLEANDER
7.		CYCUS
8.		DURANTA
9.		ASHOKA
10.		GULMOHAR

	3 SEATER BENCH
	SINGLE ARM STREET LIGHT
	DOUBLE ARM STREET LIGHT

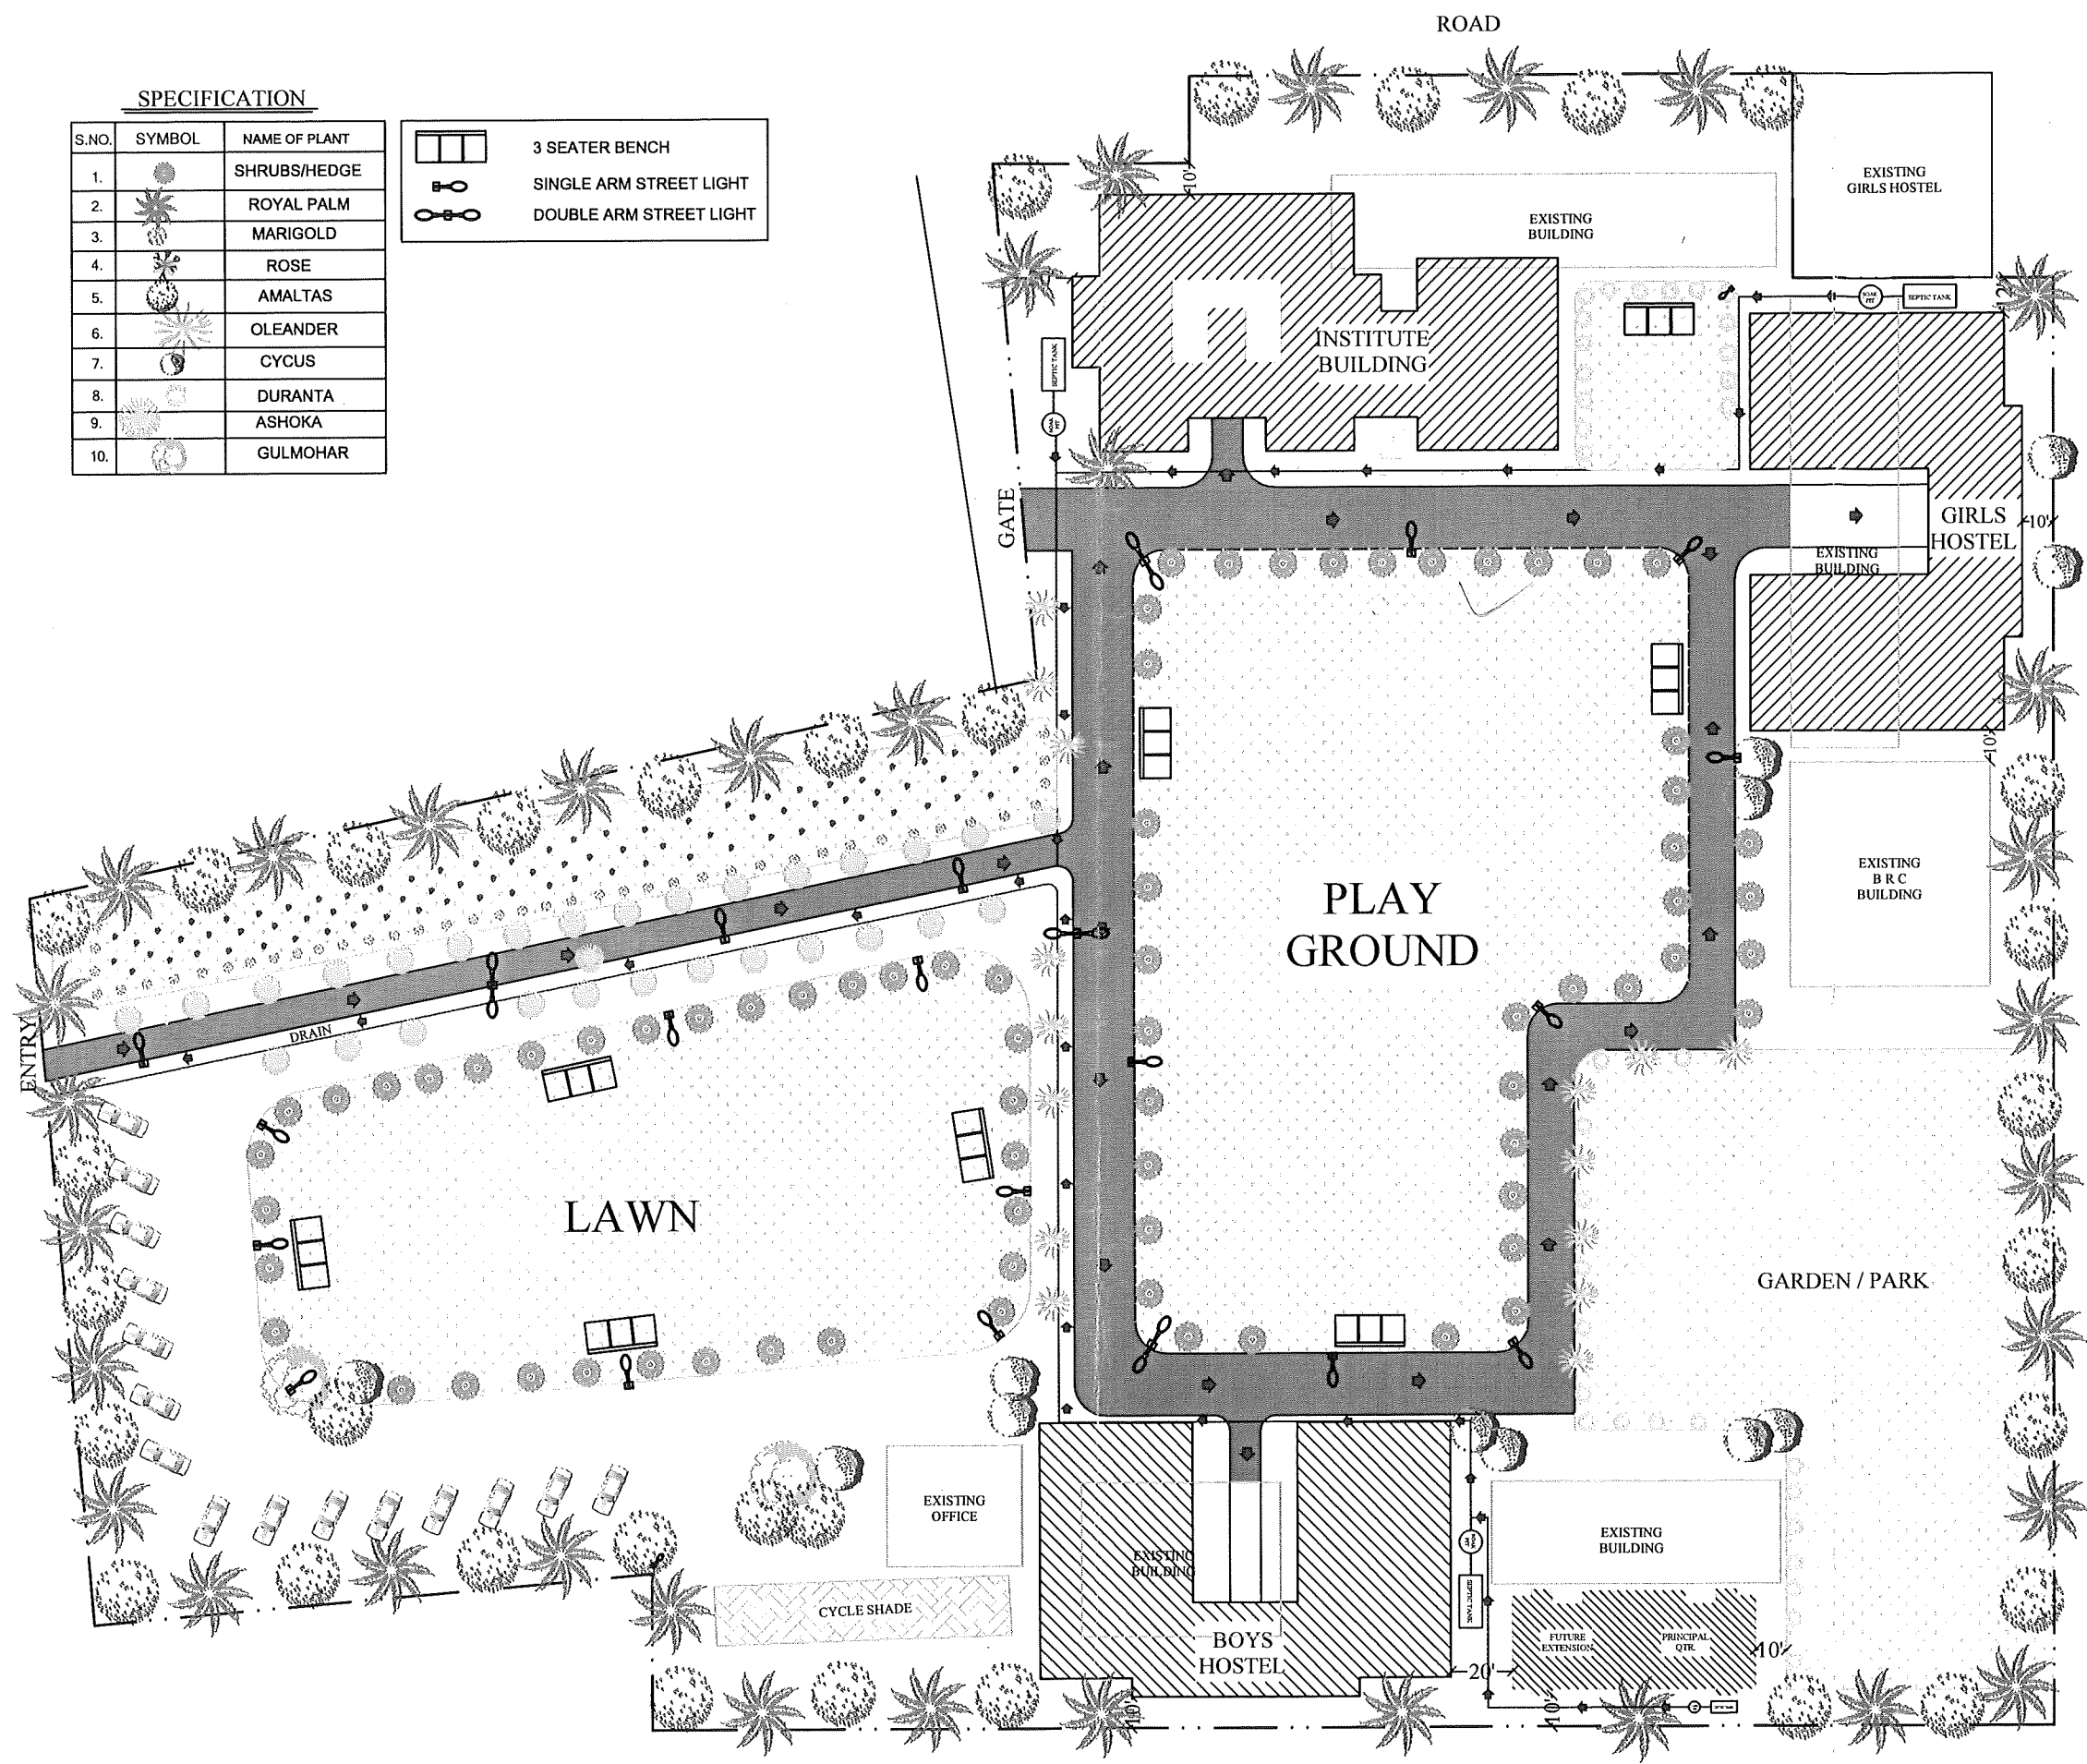

Project:- PROPOSED SITE PLAN OF PTEC BLDG. AT MASOURHI	Sheet Title: Site Plan		Date:- 10.06.18	A. Haque Draughtsman	Architect	Pankaj Kumar Sr. Architect	Bihar State Educational Infrastructure Development Corporation Ltd, Patna
		Area:-					