


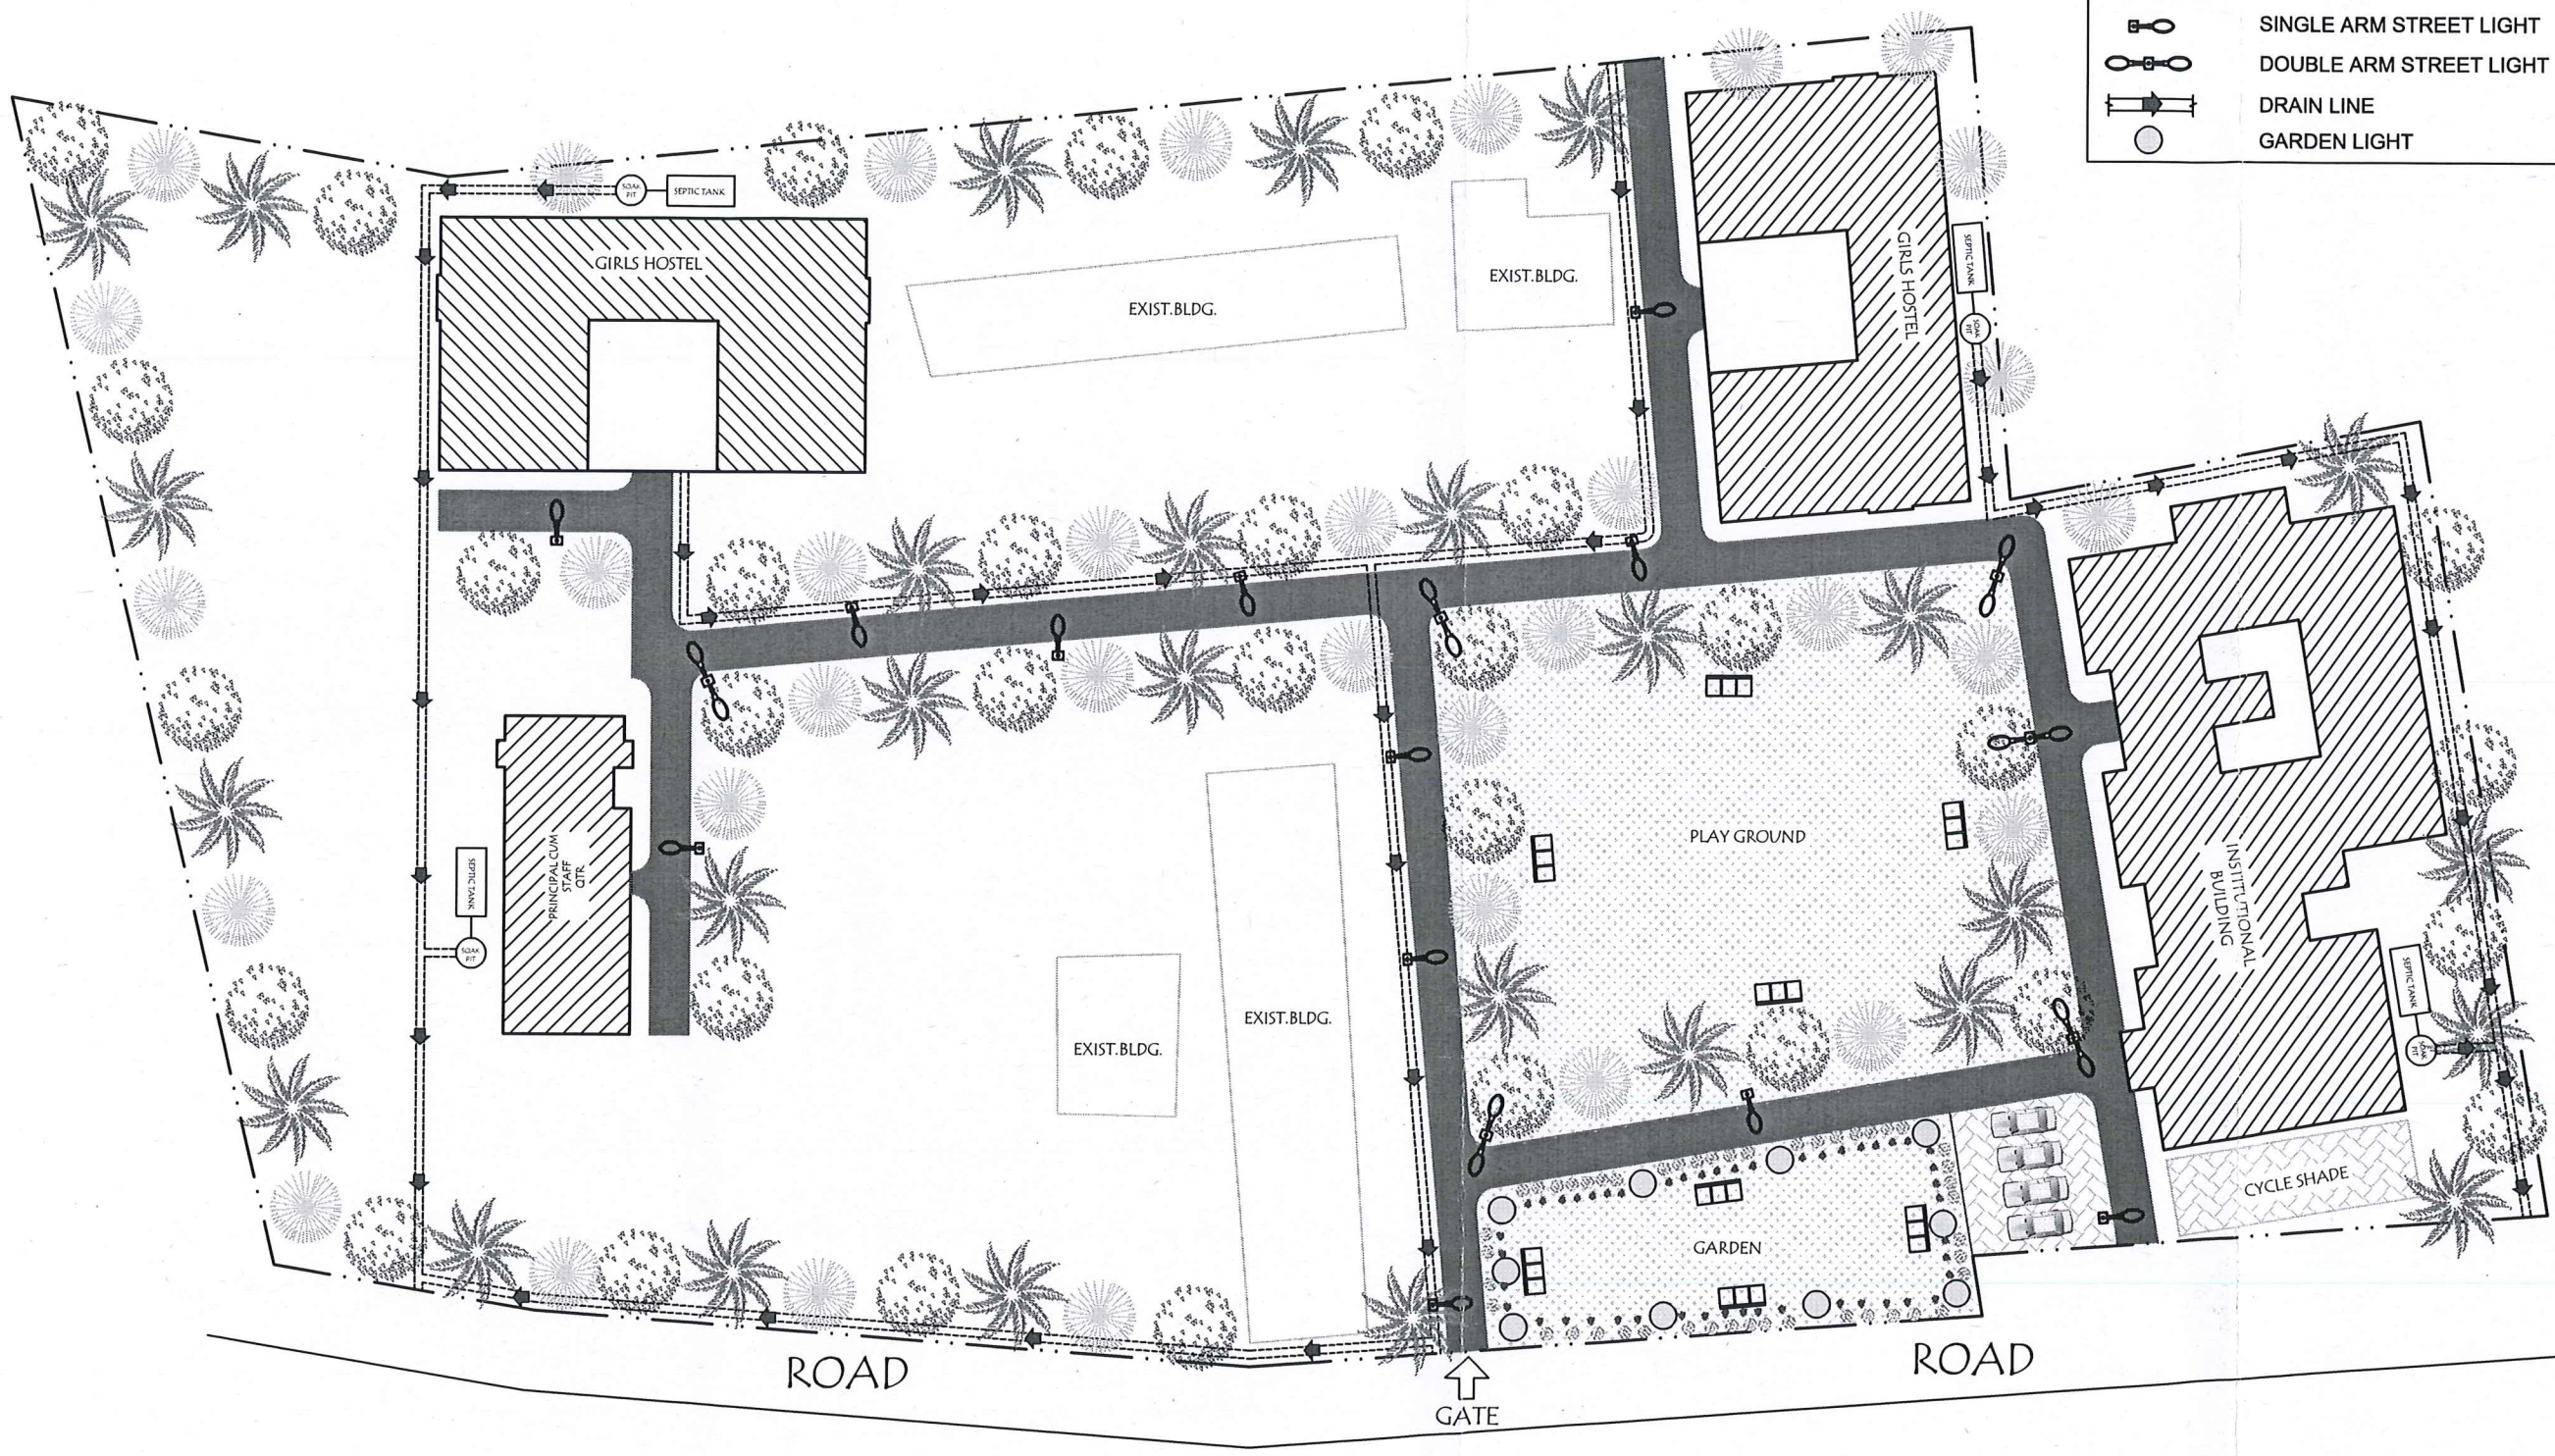

-  3 SEATER BENCH
-  SINGLE ARM STREET LIGHT
-  DOUBLE ARM STREET LIGHT
-  DRAIN LINE
-  GARDEN LIGHT

SPECIFICATION		
S.NO.	SYMBOL	NAME OF PLANT
1.		SHRUBS/HEDGE
2.		ROYAL PALM
3.		MARIGOLD
4.		ROSE
5.		AMALTAS
6.		OLEANDER
7.		CYCUS
8.		DURANTA
9.		ASHOKA

Project:-
EXISTING SITE PLAN OF PTEC BLDG.
AT NAGARPARA, BHAGALPUR

Sheet Title:
Site Plan

 Date:-
22.06.2017
Area:-

A. Haque
26.09.18
Draughtsman

Architect

Sankaj Singh
Sr. Architect

Bihar State Educational
Infrastructure Development
Corporation Ltd, Patna